



# Fire Station Renovation and Police Station Addition Camp Joseph Taylor Robinson - North Little Rock, Arkansas

Arkansas Avenue  
Date: July 1, 2016


DBA PLAN REVIEW NO # 9751650

**Stocks  
Mann** Architects, PLC  
401 W. CAPITOL, SUITE 402  
LITTLE ROCK, AR 72201  
501-370-9207 501-370-9208 (FAX)

CONSULTANTS  
DCI, Inc.  
Civil Engineer  
ROBBINS ENGINEERING  
Structural Engineer  
TME, LLC.  
MEPF Engineer

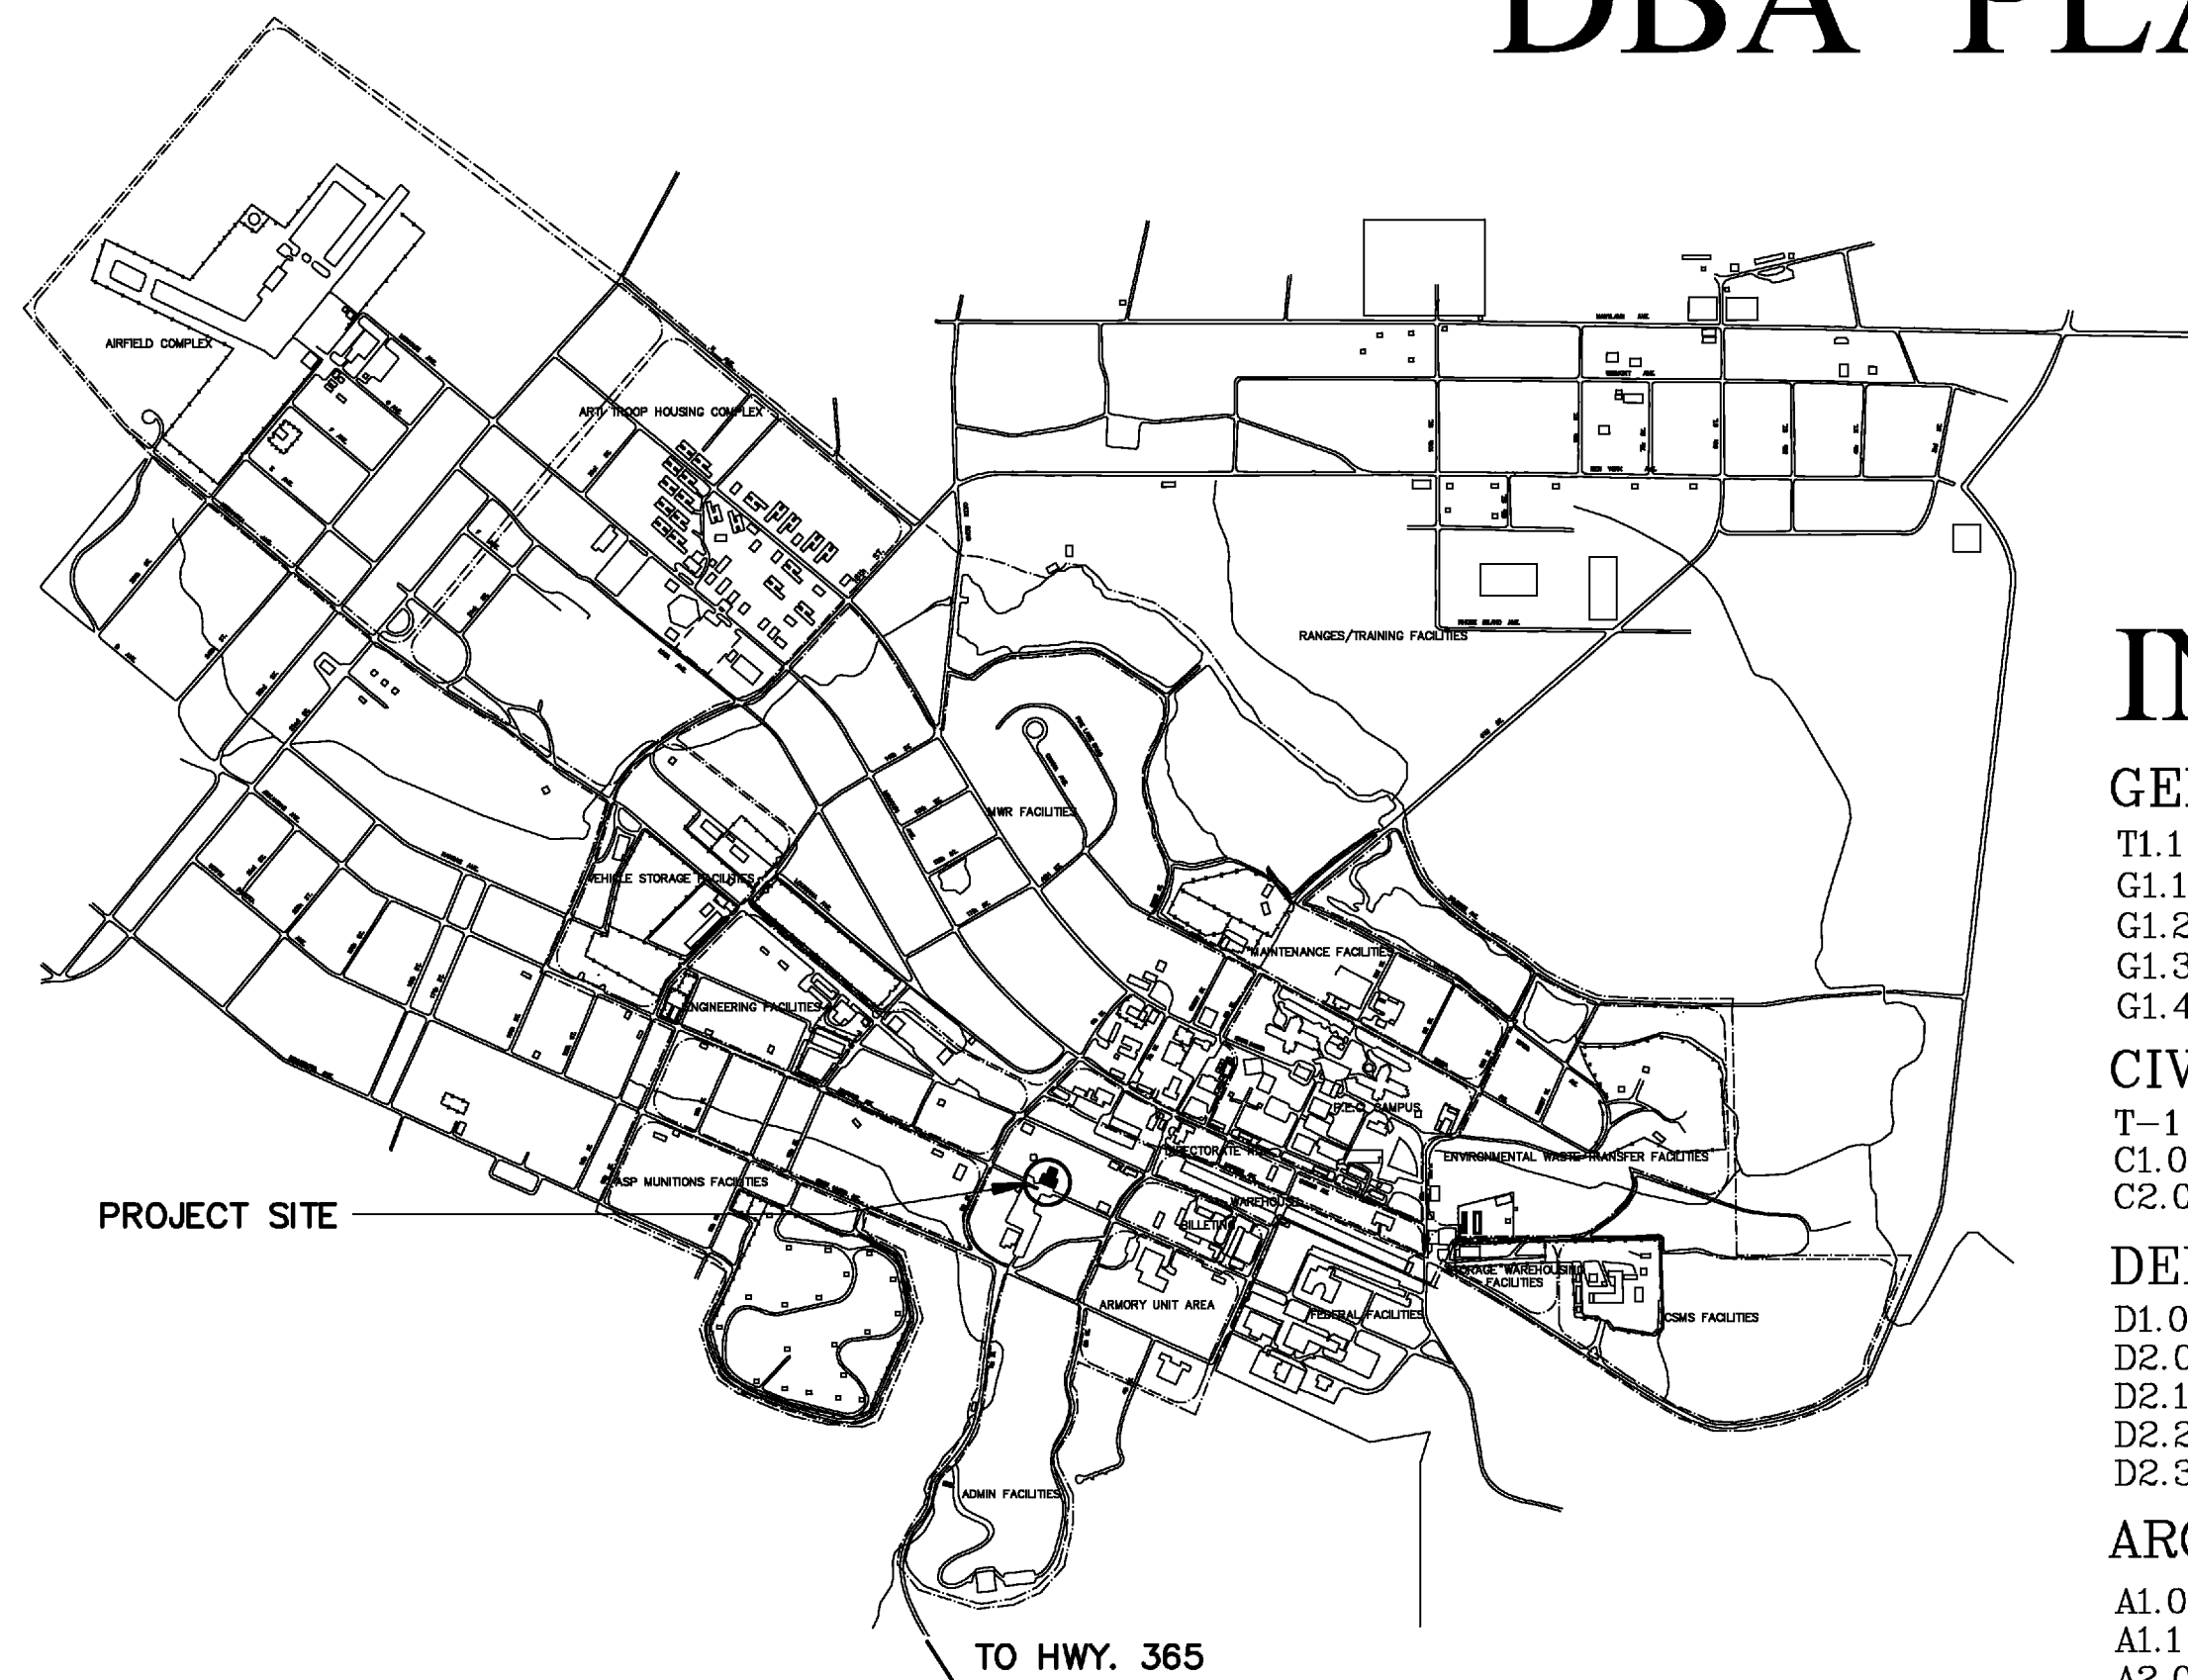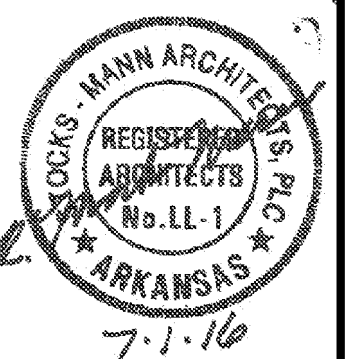

CAMP ROBINSON VICINITY MAP  
NTS

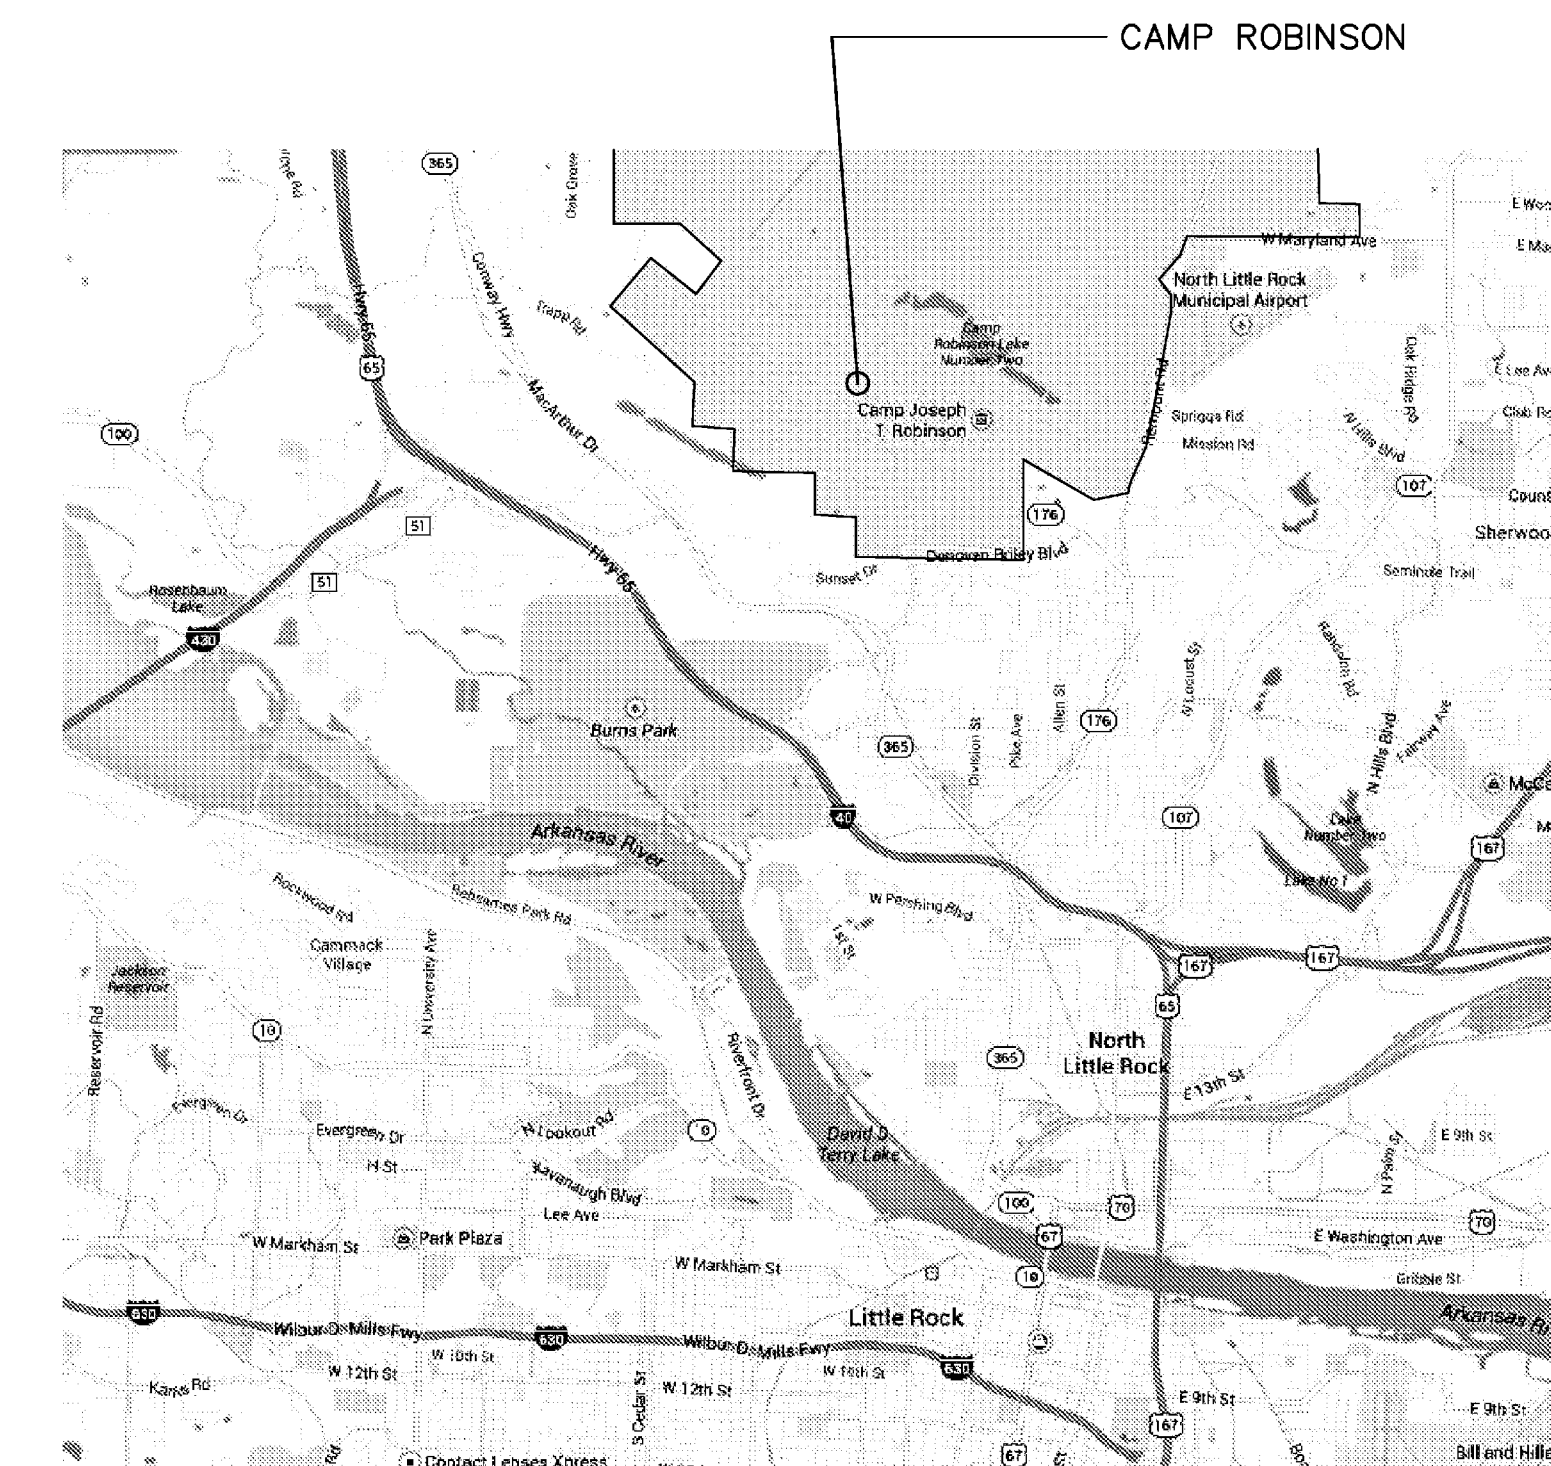

L.R. / N.L.R. AREA MAP  
NTS

## INDEX TO DRAWINGS

### GENERAL

- T1.1 TITLE SHEET
- G1.1 GENERAL INFORMATION
- G1.2 BUILDING CODE DATA
- G1.3 FIRE STOP ASSEMBLIES
- G1.4 WORK ALLOCATION PLAN

### CIVIL

- T-1 TOPOGRAPHIC SURVEY
- C1.01 GRADING AND DRAINAGE PLAN
- C2.01 UTILITY COORDINATION PLAN

### DEMOLITION

- D1.0 DEMOLITION SITE PLAN
- D2.0 DEMOLITION FLOOR PLAN
- D2.1 DEMOLITION REFLECTED CEILING PLAN
- D2.2 DEMOLITION MEZZANINE PLANS
- D2.3 DEMOLITION ROOF PLAN

### ARCHITECTURAL

- A1.0 SITE DEVELOPMENT PLAN
- A1.1 SITE DETAILS
- A2.0 KEY FLOOR PLAN
- A2.1 DIMENSIONED FLOOR PLAN
- A2.2 REFLECTED CEILING PLAN
- A2.3 MEZZANINE PLANS
- A2.4 ROOF PLAN
- A3.0 DOOR & FINISH SCHEDULES
- A3.1 FRAME SCHEDULES
- A3.2 PARTITION SCHEDULE
- A3.3 PARTITION DETAILS
- A4.0 WINDOW & DOOR DETAILS
- A4.1 WINDOW & DOOR DETAILS
- A4.2 WINDOW & DOOR DETAILS
- A4.3 WINDOW & DOOR DETAILS
- A4.4 WINDOW & DOOR DETAILS
- A5.0 BUILDING ELEVATIONS
- A6.0 BUILDING SECTIONS
- A6.1 BUILDING SECTIONS
- A7.0 ENLARGED PLANS
- A7.1 ENLARGED STAIR PLAN & SECTIONS
- A8.0 WALL SECTIONS
- A8.1 WALL SECTIONS
- A8.2 WALL SECTIONS
- A8.3 WALL SECTIONS
- A8.4 EXTERIOR DETAILS
- A8.5 EXTERIOR DETAILS
- A8.6 EXTERIOR DETAILS
- A9.0 INTERIOR ELEVATIONS
- A9.1 INTERIOR ELEVATIONS
- A9.2 INTERIOR ELEVATIONS
- A10.0 MILLWORK SECTIONS
- A10.1 MILLWORK SECTIONS

### STRUCTURAL

- S0.1 GENERAL NOTES
- S1.1 FOUNDATION PLAN
- S2.1 FOUNDATION DETAILS
- S2.2 FOUNDATION SECTIONS
- S3.1 ROOF FRAMING PLAN
- S4.1 FRAMING DETAILS
- S4.2 FRAMING SECTIONS
- S4.3 FRAMING SECTIONS

### MECHANICAL

- M0.0 GENERAL NOTES & LEGENDS - HVAC
- M0.1 SCHEDULES - HVAC
- M1.0 DEMOLITION FLOOR PLAN - HVAC
- M2.0 FLOOR PLAN - HVAC
- M3.0 DETAILS - HVAC
- M3.1 DETAILS - HVAC

### ELECTRICAL

- E0.0 SCHEDULES, LEGEND, & GENERAL NOTES - ELECTRICAL
- E0.1 SCHEDULES AND DETAILS - ELECTRICAL
- E1.0 DEMOLITION FLOOR PLAN - ELECTRICAL
- E2.0 FLOOR PLAN - LIGHTING
- E3.0 FLOOR PLAN - POWER
- E4.0 FLOOR PLAN - SYSTEMS
- E5.0 RISER DIAGRAMS - ELECTRICAL
- E6.0 PANEL SCHEDULES - ELECTRICAL

### PLUMBING

- P0.0 SCHEDULES, LEGEND, AND GENERAL NOTES - PLUMBING
- P1.0 DEMOLITION FLOOR PLAN - PLUMBING
- P2.0 FLOOR PLAN - PLUMBING
- P3.0 ENLARGED FLOOR PLAN - PLUMBING
- P4.0 RISERS - PLUMBING
- P5.0 DETAILS - PLUMBING

### FIRE PROTECTION

- F0.0 DETAILS - FIRE PROTECTION
- F0.1 GENERAL NOTES & RISER DETAILS - FIRE PROTECTION
- F1.0 FLOOR PLAN - FIRE PROTECTION
- F2.0 ATTIC PLAN - FIRE PROTECTION

#### CIVIL ENGINEER

DEVELOPMENT CONSULTANTS, INC.  
2200 NORTH RODNEY PARHAM, STE. 220  
LITTLE ROCK, ARKANSAS 72212  
(501) 221-7880

#### STRUCTURAL ENGINEER

ROBBINS ENGINEERING, INC.  
10018 WEST MARKHAM  
LITTLE ROCK, ARKANSAS 72205  
(501) 664-7575

#### MECH., ELECT. & FIRE PROTECTION ENGINEER

TINSLEY-MULLEN ENGINEERS  
1 ALLIED DRIVE, SUITE 2600  
LITTLE ROCK, ARKANSAS 72202  
(501) 666-8776

I hereby certify that these plans and specifications have been prepared by me, or under my supervision. I further certify that to the best of my knowledge these plans and specifications are as required by law and in compliance with the ARKANSAS FIRE PREVENTION CODE for the State of Arkansas.

*R. Mark Mann*

R. Mark Mann

AR Registration No. 1509

Fire Station Renovation and  
Police Station Addition  
Building 7200 - Camp Joseph T. Robinson  
North Little Rock, Arkansas

#### REVISIONS

#### ISSUE DATE

JULY 1, 2016

#### PROJECT NO.

0901U

#### CONTENTS

TITLE SHEET

#### SHEET NUMBER

T1.1