


**Fire Station Renovation and
Police Station Addition**
Building 7200 - Camp Joseph T. Robinson
North Little Rock, Arkansas

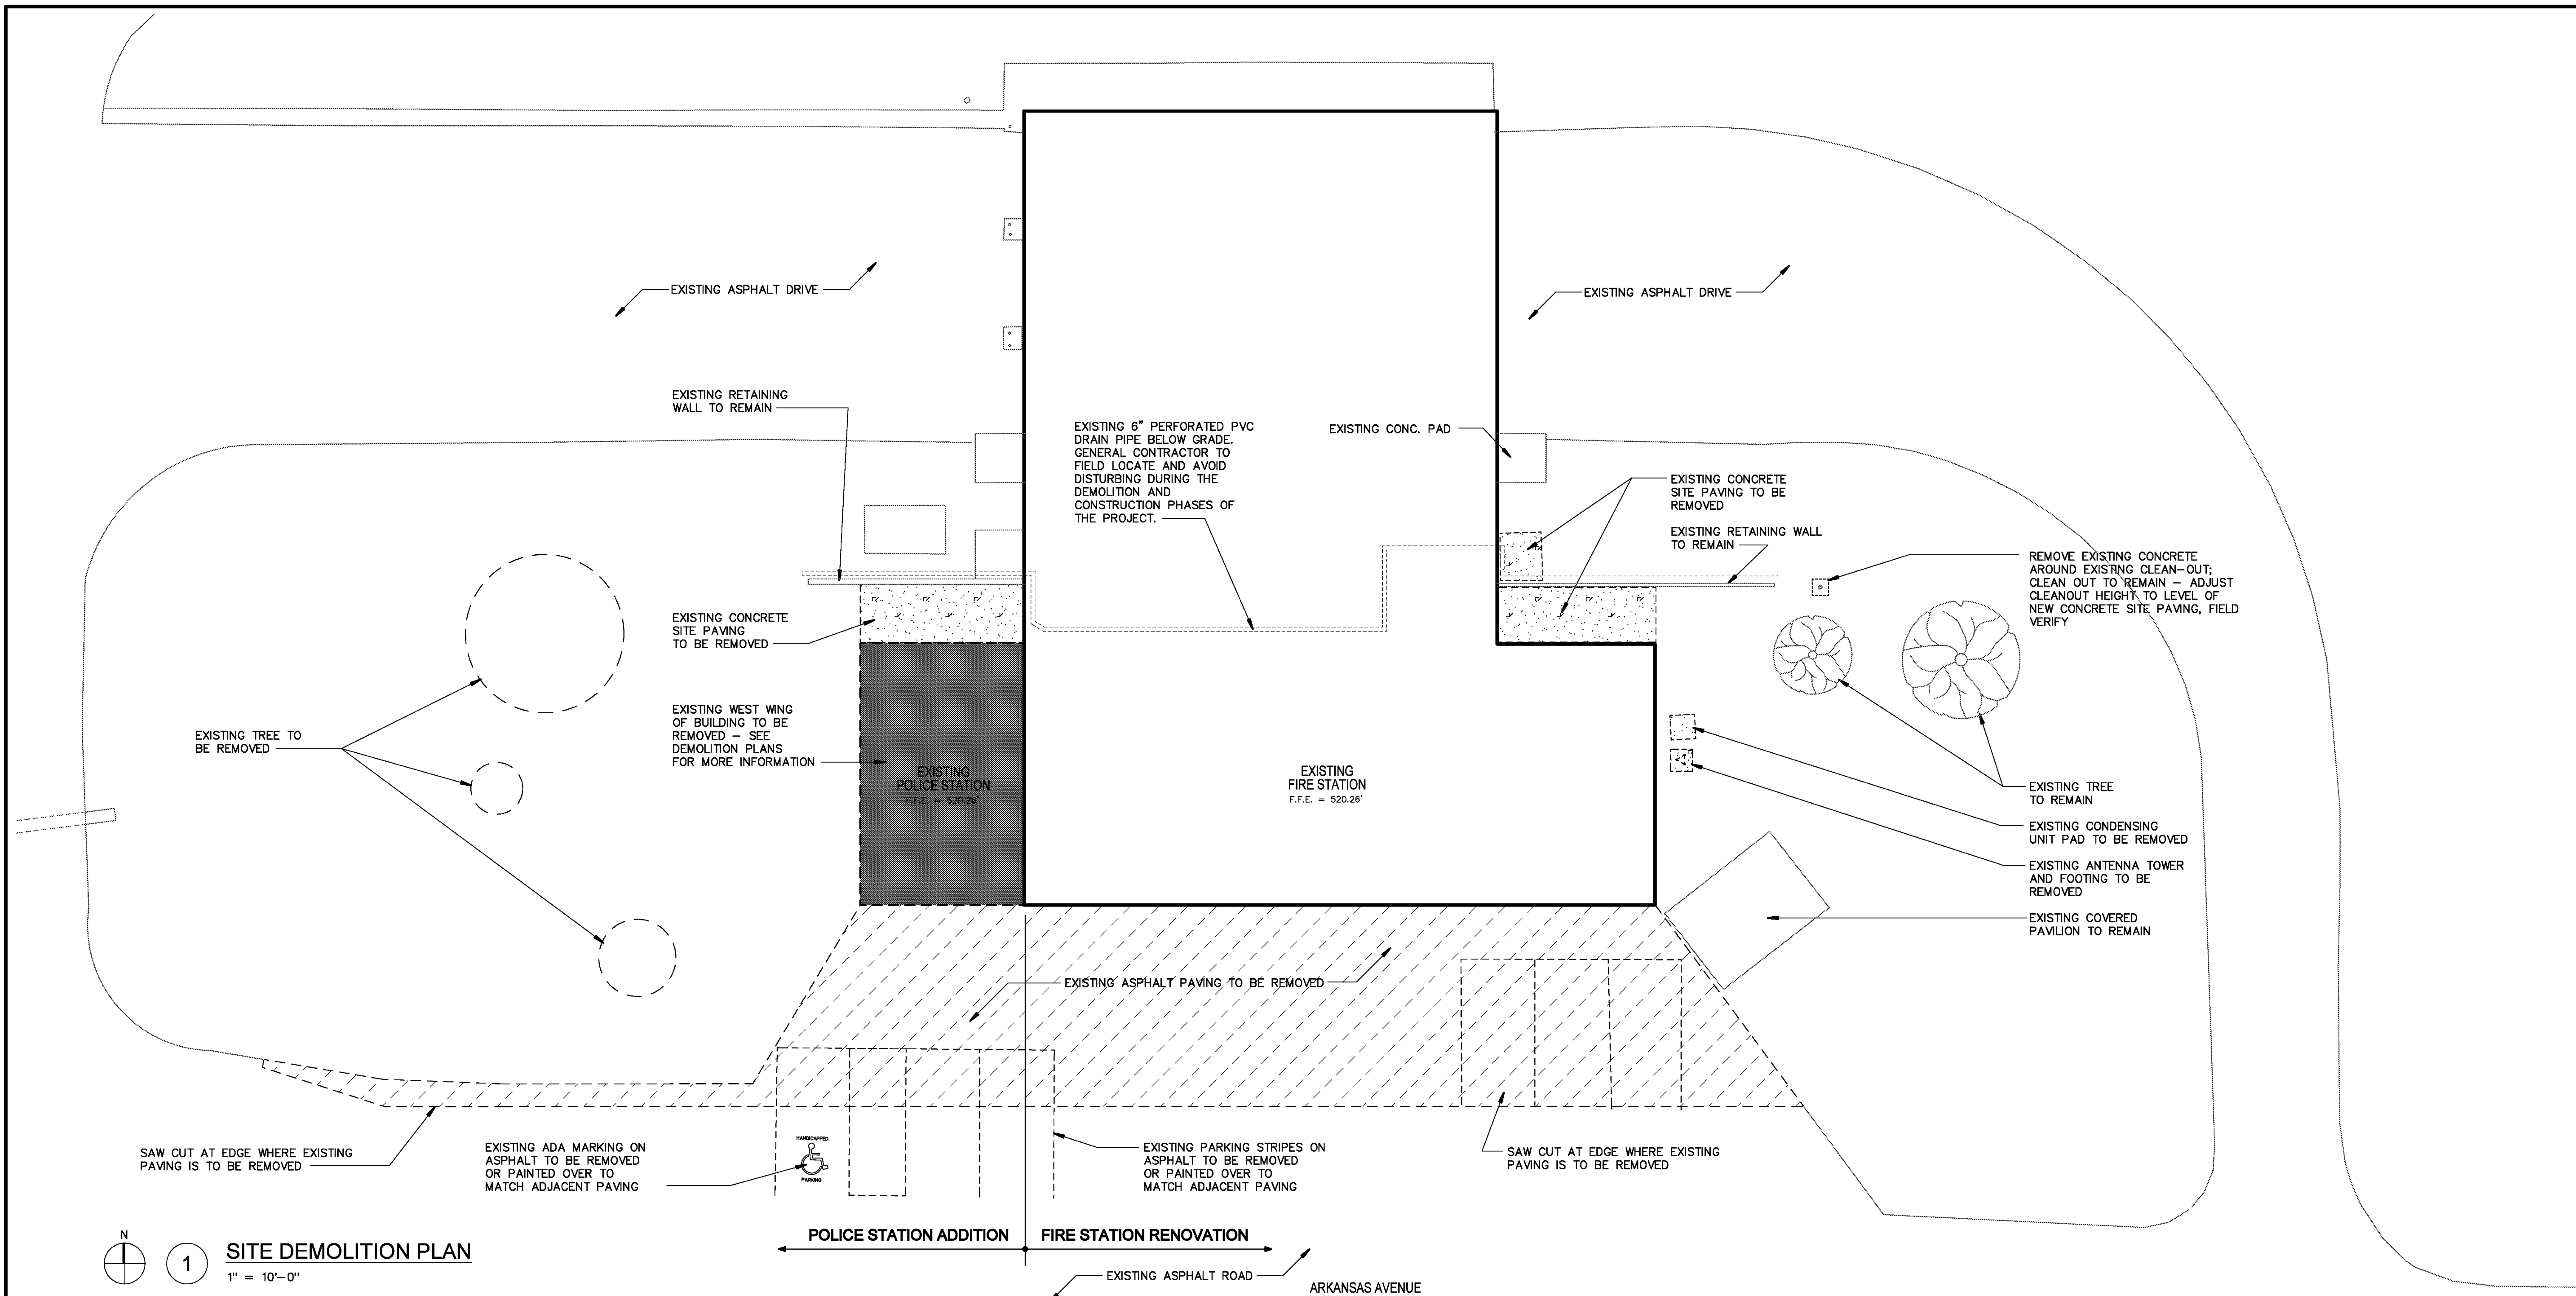

1 **SITE DEMOLITION PLAN**
1" = 10'-0"

SITE DEMOLITION GENERAL NOTES

1. THE GENERAL CONTRACTOR IS TO VERIFY EXISTING CONDITIONS. IF ACTUAL CONDITIONS ARE FOUND TO BE OTHER THAN SHOWN IN THE DRAWINGS THE GENERAL CONTRACTOR IS TO NOTIFY THE ARCHITECT OF THE DISCREPANCIES.
2. GENERAL CONTRACTOR SHALL BE RESPONSIBLE FOR FAMILIARIZATION WITH EXISTING SITE CONDITIONS.
3. WHERE SCHEDULED FOR REMOVAL, SAW CUT CONCRETE, ASPHALT, ETC., PRIOR TO REMOVAL.
4. GENERAL CONTRACTOR SHALL BE RESPONSIBLE FOR THE PROTECTION OF EXISTING CONCRETE PAVING AND ASPHALT PAVING SCHEDULED TO REMAIN AND SHALL BE RESPONSIBLE FOR THE REPAIR OF DAMAGED SIDEWALKS AND CURBS/GUTTERS. GENERAL CONTRACTOR SHALL PROVIDE AN ASSESSMENT OF EXISTING DAMAGE NOT TO BE HELD ACCOUNTABLE FOR.
5. GENERAL CONTRACTOR SHALL BE RESPONSIBLE FOR THE PROTECTION OF EXISTING UTILITIES NOT SCHEDULED FOR REMOVAL AND SHALL BE RESPONSIBLE FOR THE REPAIR OF DAMAGED UTILITIES OR INTERRUPTED AS A RESULT OF THIS CONSTRUCTION PROJECT.
6. DASHED LINES INDICATE ITEMS TO BE REMOVED UNLESS NOTED OTHERWISE.
7. SEE STRUCTURAL, MECHANICAL, PLUMBING, AND ELECTRICAL DEMOLITION PLANS FOR THOSE ITEMS TO BE DEMOLISHED.
8. POINT OF CONTACT AND CAMP UTILITIES CONTACTS
FOR TELEPHONE AND FIBER: MAJOR BROOK ELLIS, PH: 212-5925
FOR ELECTRICAL: HANS PETERSON, PH: 212-5211
FOR SEWER AND GAS: CHUCK CHWALNSKI, PH: 212-5229, CELL: 773-3368
POINT OF CONTACT: ISG MICHAEL FOSLER, FACILITIES MANAGEMENT OFFICE, PH: 212-5853, CELL: 837-1265

REVISIONS

NO.	DATE	DESCRIPTION

ISSUE DATE
JULY 1, 2016

PROJECT NO.
0901U

CONTENTS
DEMOLITION
SITE PLAN

SHEET NUMBER

D1.0