


**KEYED NOTES:**

- ① EXISTING PANELS: EXISTING TO REMAIN. MAINTAIN INTEGRITY OF EXISTING ELECTRICAL CONNECTIONS TO PANELS. RE-LABEL PANEL "7200" AS PANEL "E1". RE-LABEL PANEL "7200B" AS PANEL "N1". UPDATE LABELING ON BOTH PANELS TO CORRESPOND TO NAME CHANGE. EXISTING LABELING ON PANELS SHALL ALSO REMAIN.
- ② DISTRIBUTION PANEL: EXISTING TO REMAIN. PANEL SHALL REMAIN IN PLACE DURING DEMOLITION. FASTEN PANEL TO NEW WALL.
- ③ AREA OF DEMOLITION: LIGHTING, ELECTRICAL DEVICES, AND WIRING IN THIS AREA SHALL BE REMOVED AND DEMOLISHED UNLESS NOTED OTHERWISE.
- ④ ELECTRICAL DEVICES IN THIS AREA ARE EXISTING TO REMAIN.
- ⑤ LIGHTING CONTACTORS AND TIME CLOCK: EXISTING TO REMAIN.
- ⑥ REMOVE RECEPTACLE AND NON-WEATHER PROTECTED HANDY BOX INSTALLED IN EXISTING PAVILION. EXISTING CONDUIT AND CONDUCTORS SERVING LOCATION ARE EXISTING TO REMAIN.
- ⑦ EXISTING COMMUNICATIONS TOWER: ELECTRICAL CONTRACTOR SHALL COORDINATE WITH OWNER AND COMMUNICATIONS VENDOR. DEMOLITION AND INSTALLATION OF STRUCTURAL TOWER BY OTHERS. DEMOLITION AND INSTALLATION OF CABLING AND ANTENNAS BY COMMUNICATIONS VENDOR. GROUNDING AND PATHWAYS FOR TOWER BY ELECTRICAL CONTRACTOR.
- ⑧ WEST POLE LIGHT DISCONNECT: DEMOLISH DISCONNECT. DEMOLISH ASSOCIATED WIRING FROM DISCONNECT TO WEST POLE LIGHT.
- ⑨ DISCONNECT: EXISTING TO REMAIN.
- ⑩ DISCONNECT: DEMOLISH AND REMOVE ASSOCIATED WIRING.
- ⑪ EXISTING DIRECT-BURIAL POLE LIGHT: REMOVE AND RELOCATE. VERIFY AND RECORD BURIAL DEPTH OF EXISTING POLE LIGHT BEFORE REMOVAL. REFER TO SHEET E2.0 FOR NEW LOCATION OF EXISTING POLE LIGHT.

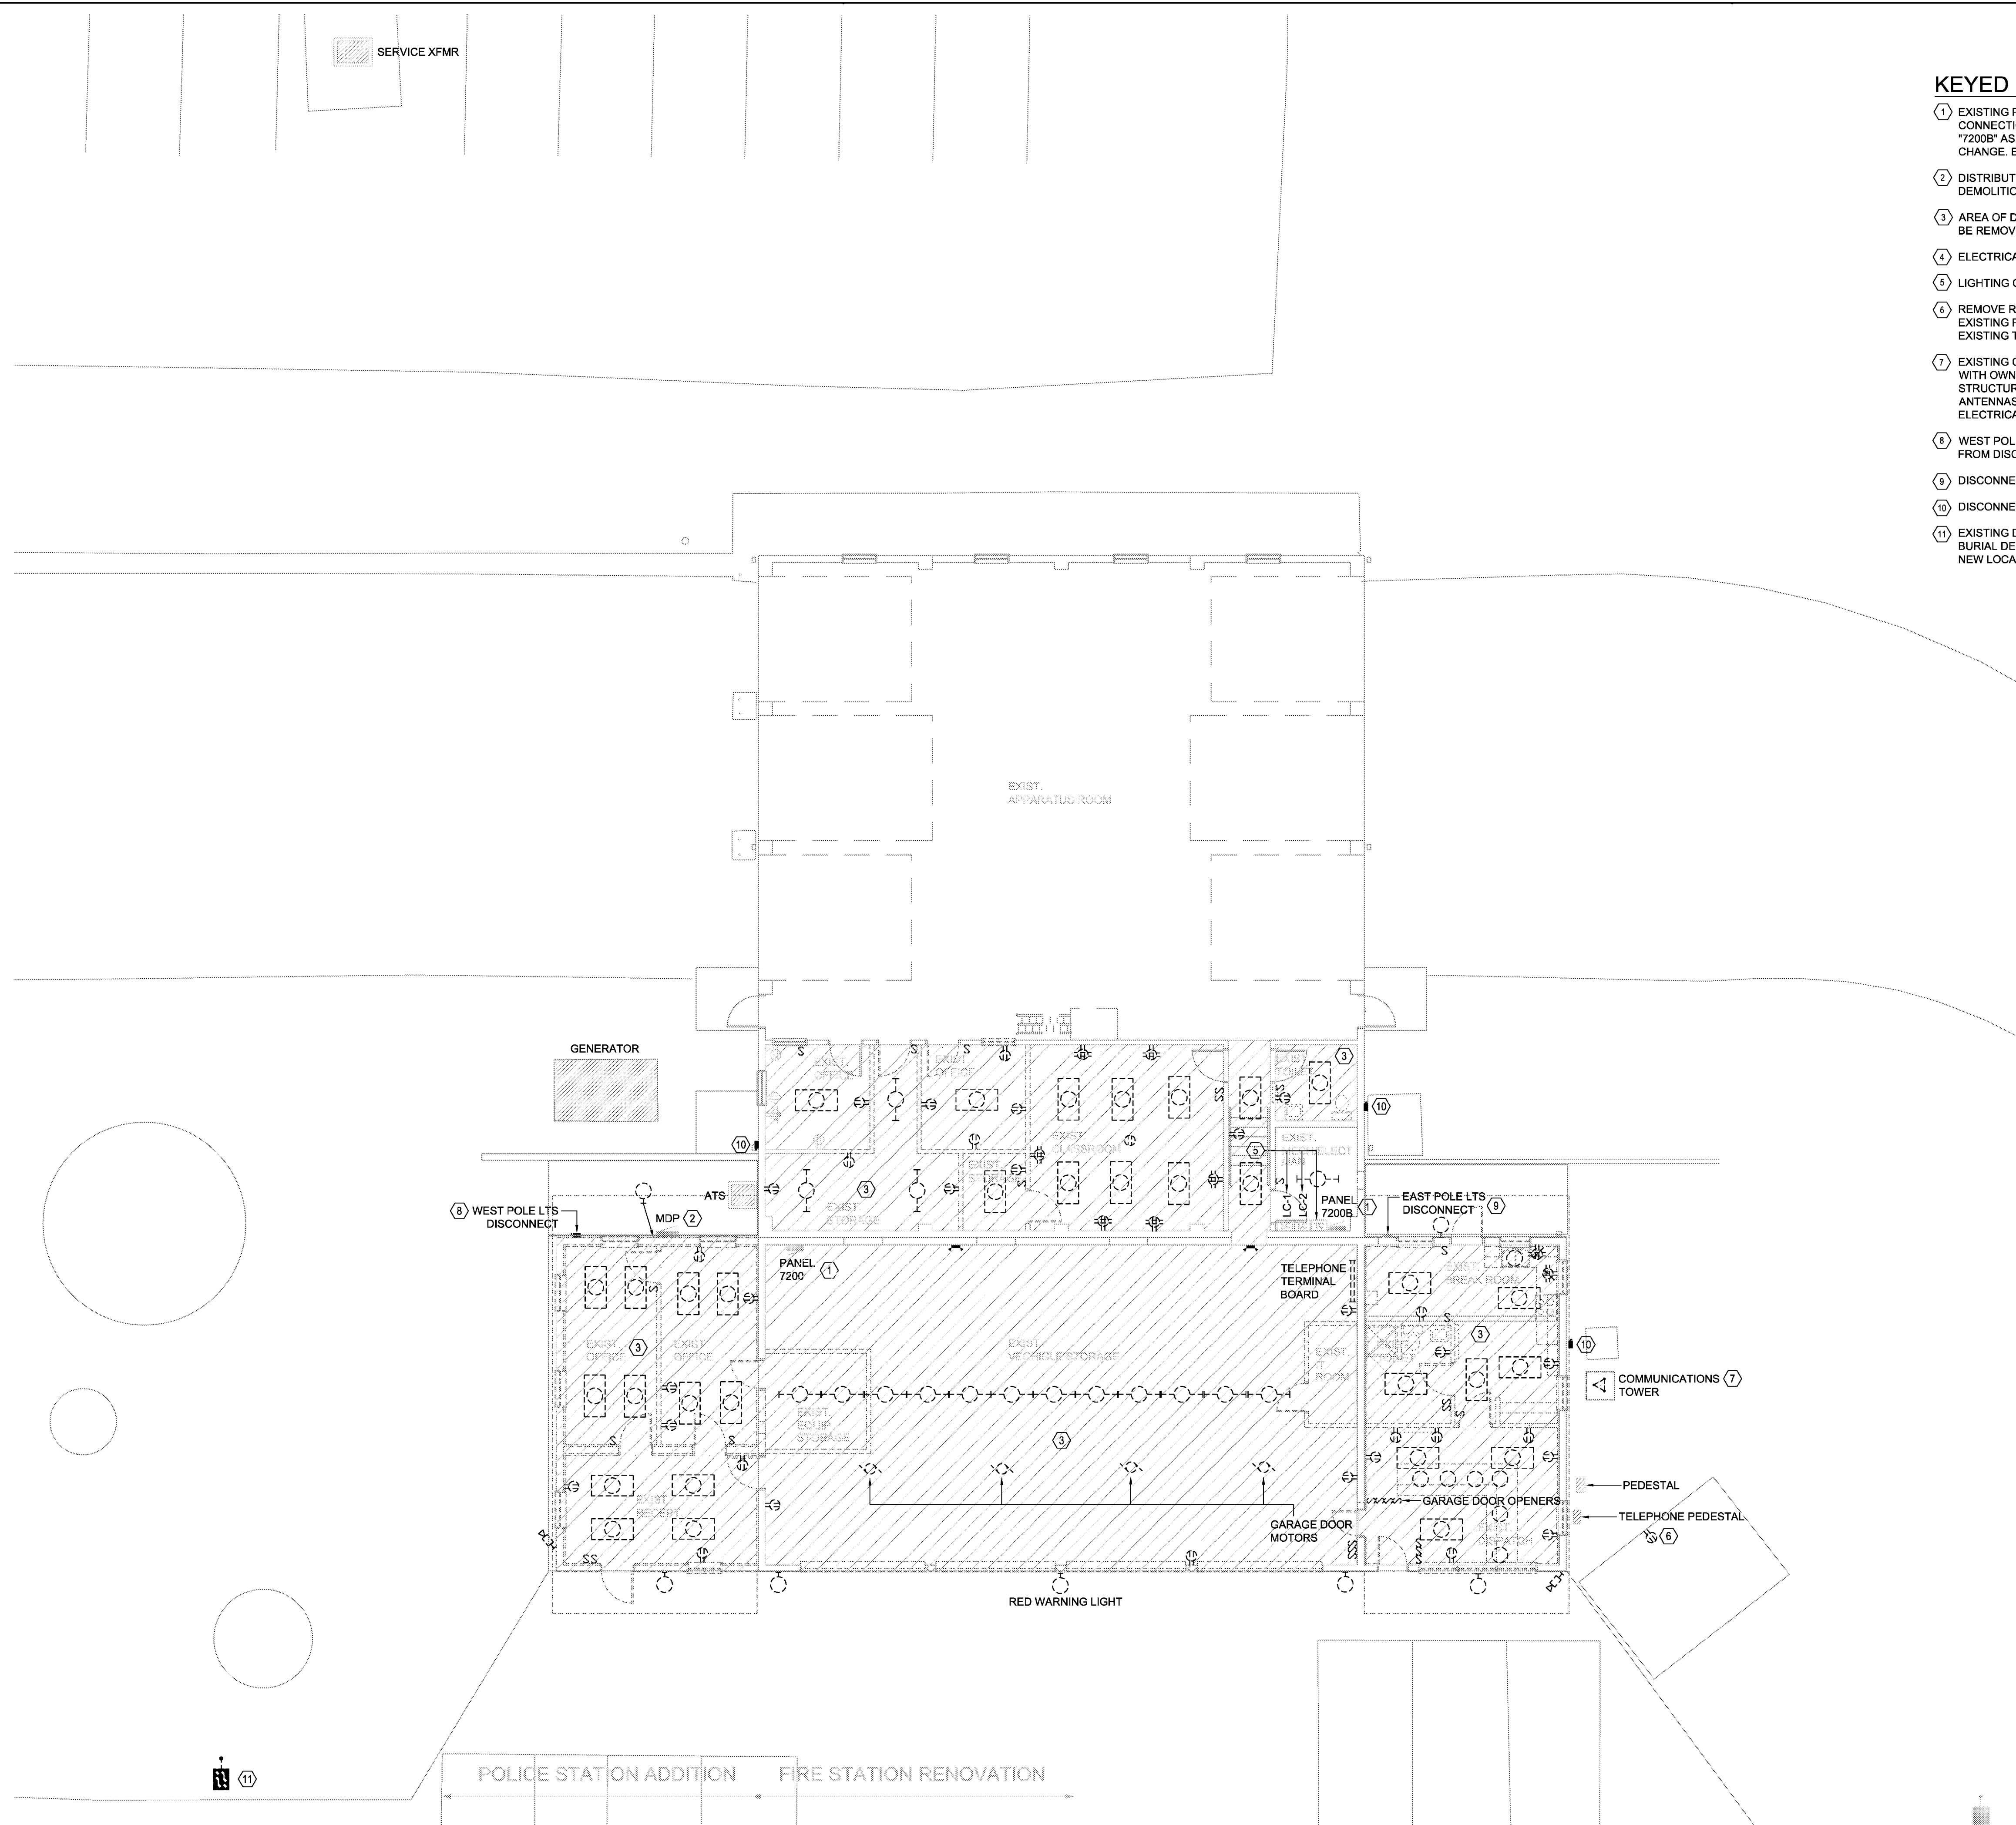

**Fire Station Renovation and  
Police Station Addition**  
Building 7200 - Camp Joseph T. Robinson  
North Little Rock, Arkansas

REVISIONS


ISSUE DATE  
07/01/2016

PROJECT NO.  
0901U

CONTENTS  
DEMOLITION  
FLOOR PLAN -  
ELECTRICAL

SHEET NUMBER

**E1.0**

1 DEMOLITION FLOOR PLAN - ELECTRICAL  
1/8" = 1'-0"