

*Handwritten signature: Howard*  
7/1/16

**Fire Station Renovation and  
Police Station Addition**  
Building 7200 - Camp Joseph T. Robinson  
North Little Rock, Arkansas

**REVISIONS**

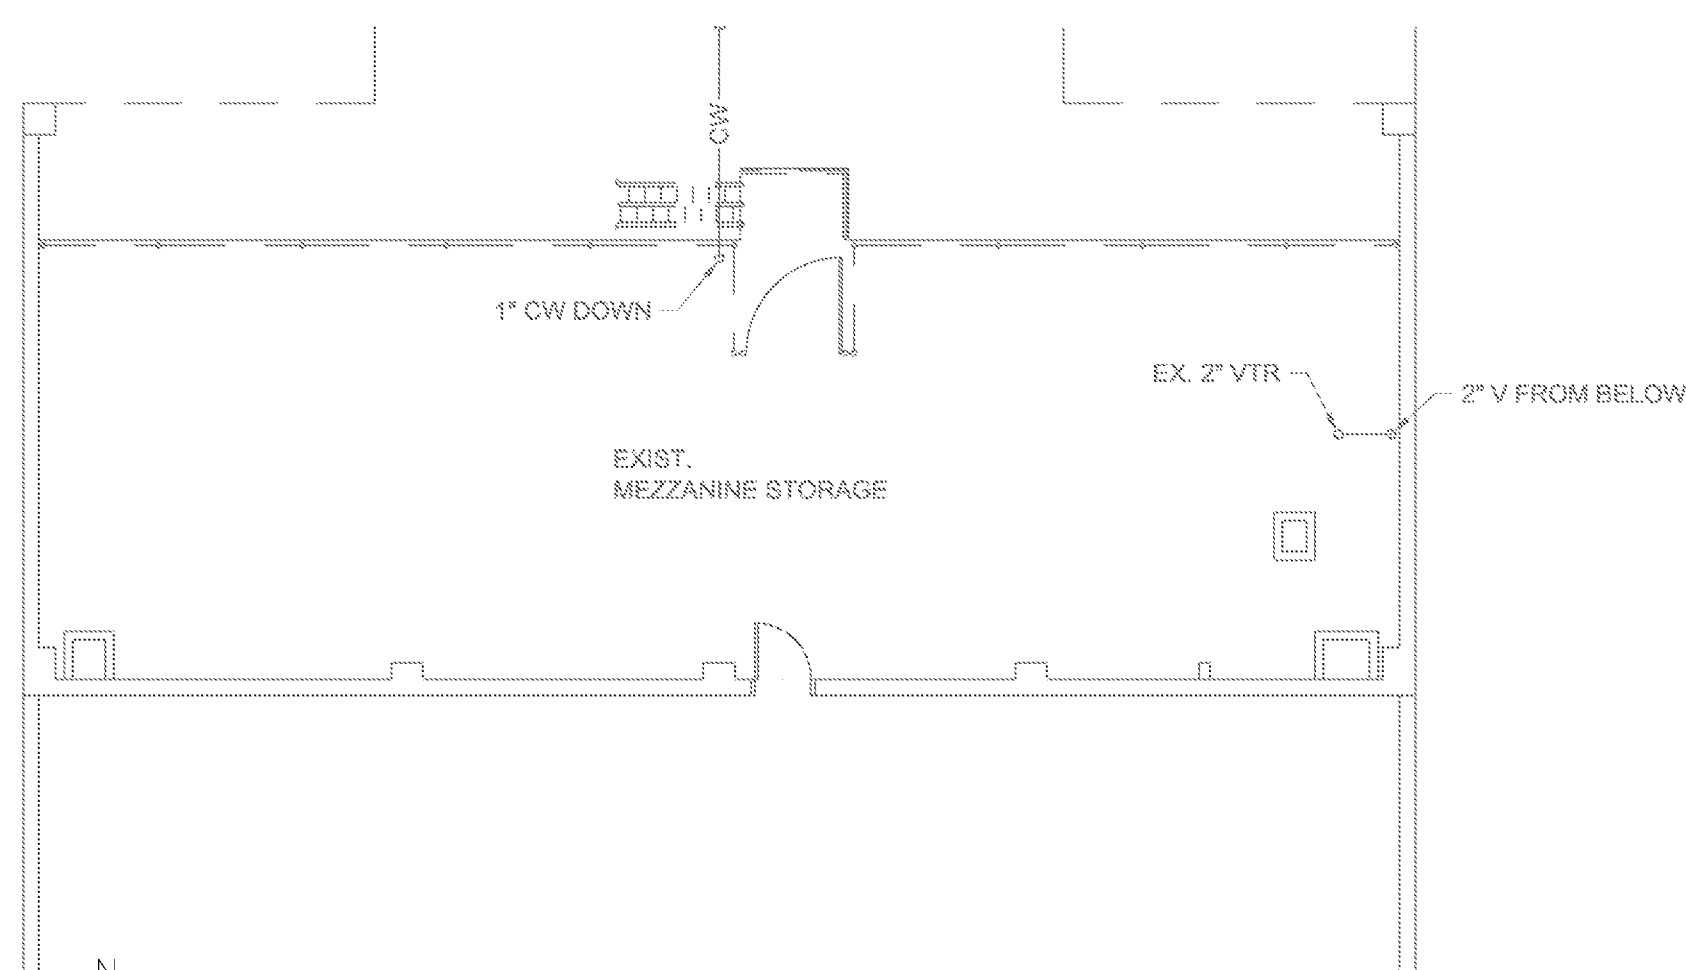

ISSUE DATE  
07/01/2016

PROJECT NO.  
0901U


CONTENTS  
DEMOLITION  
FLOOR PLAN -  
PLUMBING

SHEET NUMBER

**P1.0**



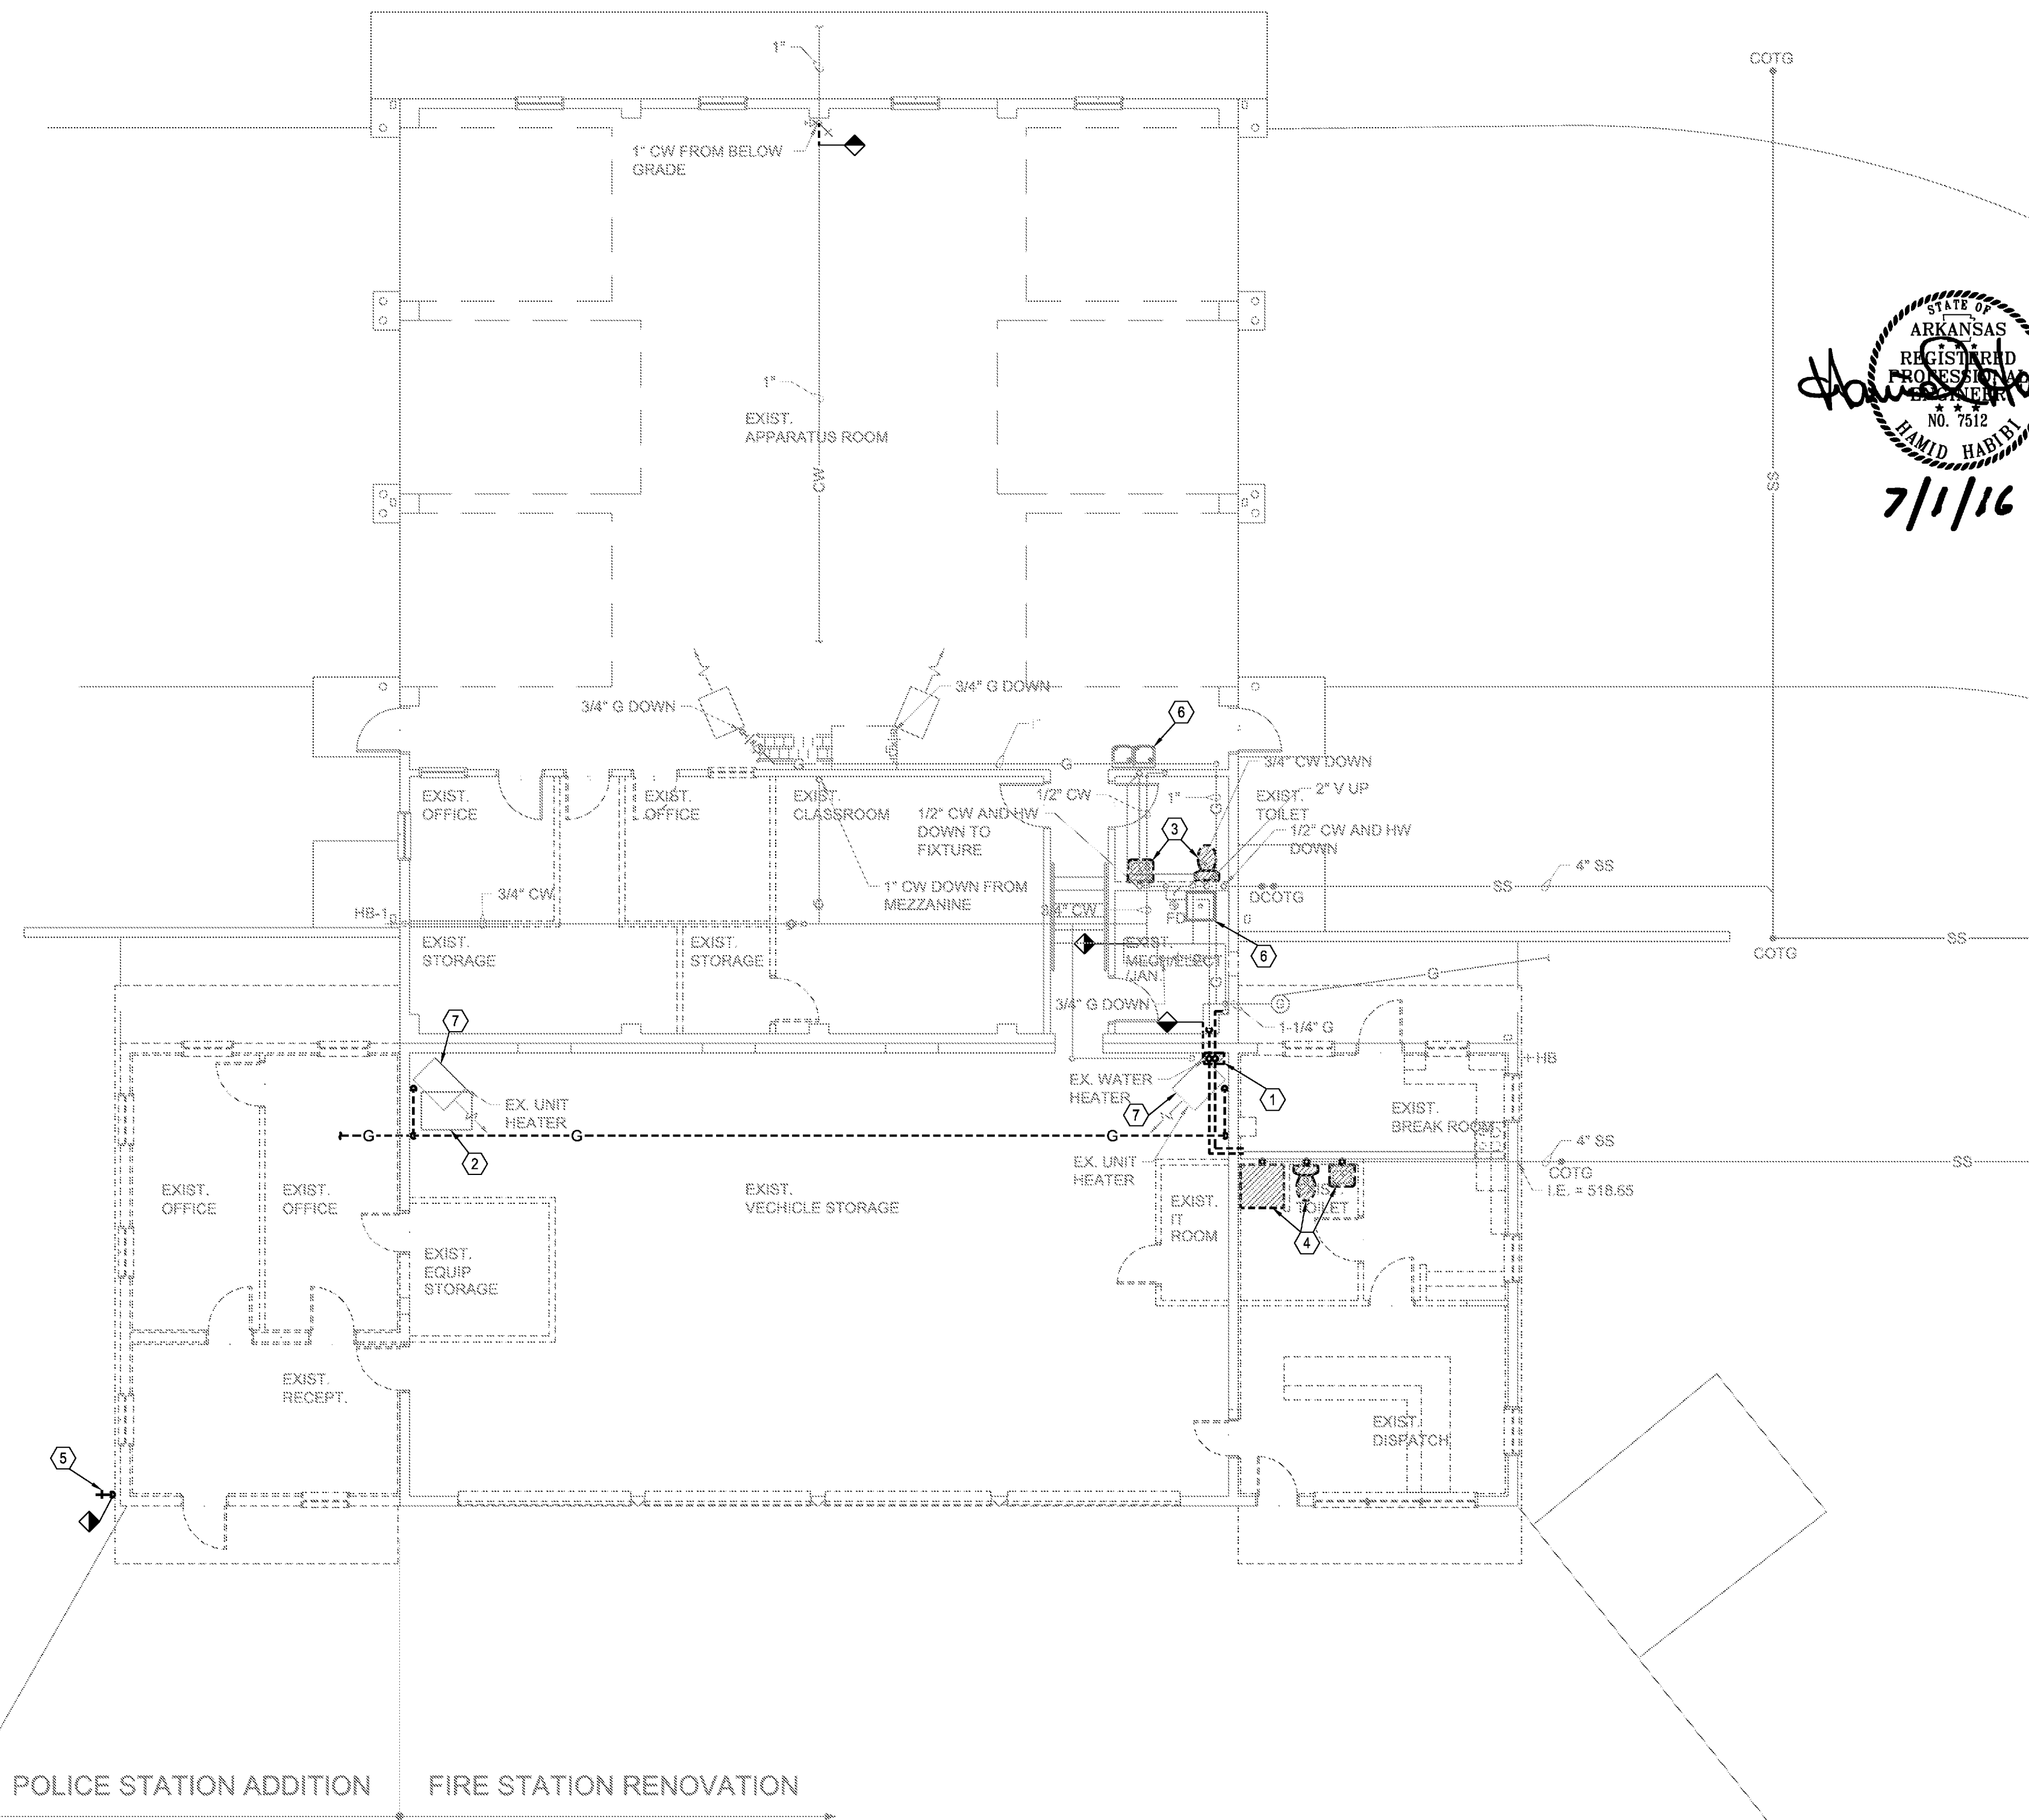**2 DEMOLITION MEZZANINE PLAN - PLUMBING**  
1/8" = 1'-0"



**1 DEMOLITION FLOOR PLAN - PLUMBING**  
1/8" = 1'-0"

**KEYED DEMOLITION NOTES:**

- ① EXISTING WALL MOUNTED INSTANTANEOUS WATER HEATER TO BE REMOVED AND RELOCATED.
- ② EXISTING BREATHING AIR MODULE UNIT TO BE REMOVED.
- ③ REMOVE EXISTING PLUMBING FIXTURE. EXISTING ROUGH-IN TO BE REUSED.
- ④ REMOVED EXISTING PLUMBING FIXTURE AND ROUGH-IN.
- ⑤ REMOVE EXISTING HOSE BIBB.
- ⑥ EXISTING FIXTURE TO REMAIN.
- ⑦ EXISTING UNIT HEATERS TO BE REMOVED. REFER TO MECHANICAL DRAWINGS.

POLICE STATION ADDITION FIRE STATION RENOVATION