

Handwritten Signature
7/1/16

**Fire Station Renovation and
Police Station Addition**
Building 7200 - Camp Joseph T. Robinson
North Little Rock, Arkansas


REVISIONS

ISSUE DATE
07/01/2016
PROJECT NO.
0901U

CONTENTS
FLOOR PLAN -
PLUMBING


SHEET NUMBER

P2.0

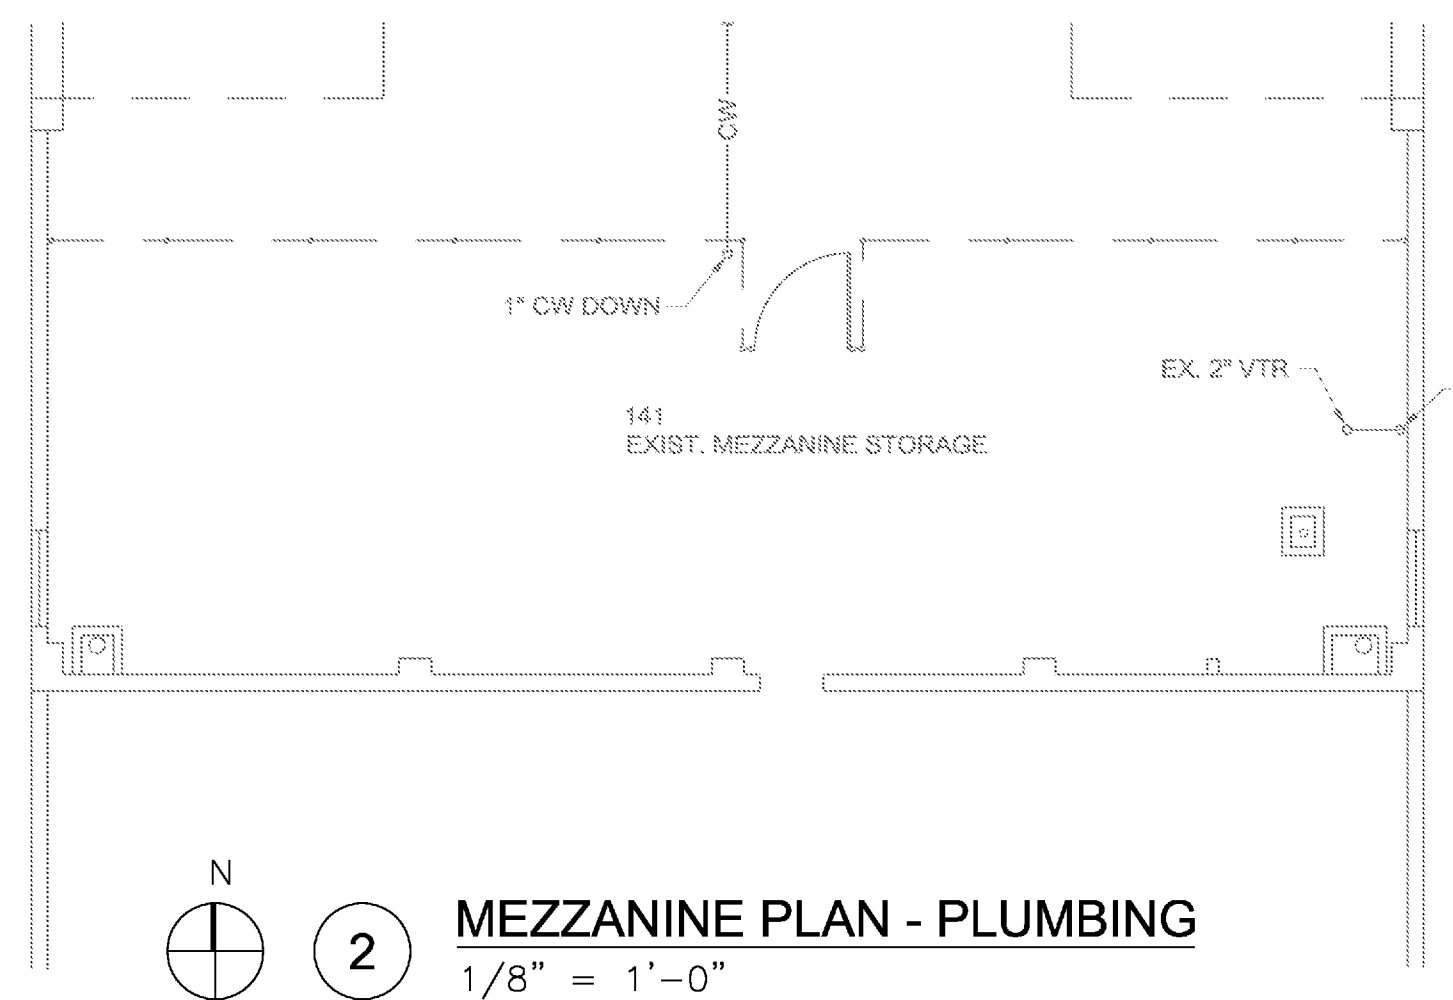


2 MEZZANINE PLAN - PLUMBING
1/8" = 1'-0"

- GENERAL PLUMBING NOTE:**
- CONTRACTOR TO FIELD VERIFY EXISTING SANITARY SEWER INVERT ELEVATIONS.
- KEYED PLUMBING NOTES:**
- 1/2" CW AND HW DOWN TO WB-1. REWORK EXISTING ROUGH-INS IN WALL AS NECESSARY TO MAKE CONNECTIONS.
 - EXISTING RELOCATED INSTANTANEOUS WATER HEATER.
 - CONNECT NEW 2" VENT ABOVE CEILING TO NEAREST EXISTING VENT THRU ROOF.
 - GAS DISCONNECT VALVE TO BE SPECIFIED WITH HOOD. REFER TO MECHANICAL SPECIFICATIONS. ELECTRICAL CONTRACTOR TO PROVIDE POWER TO VALVE.

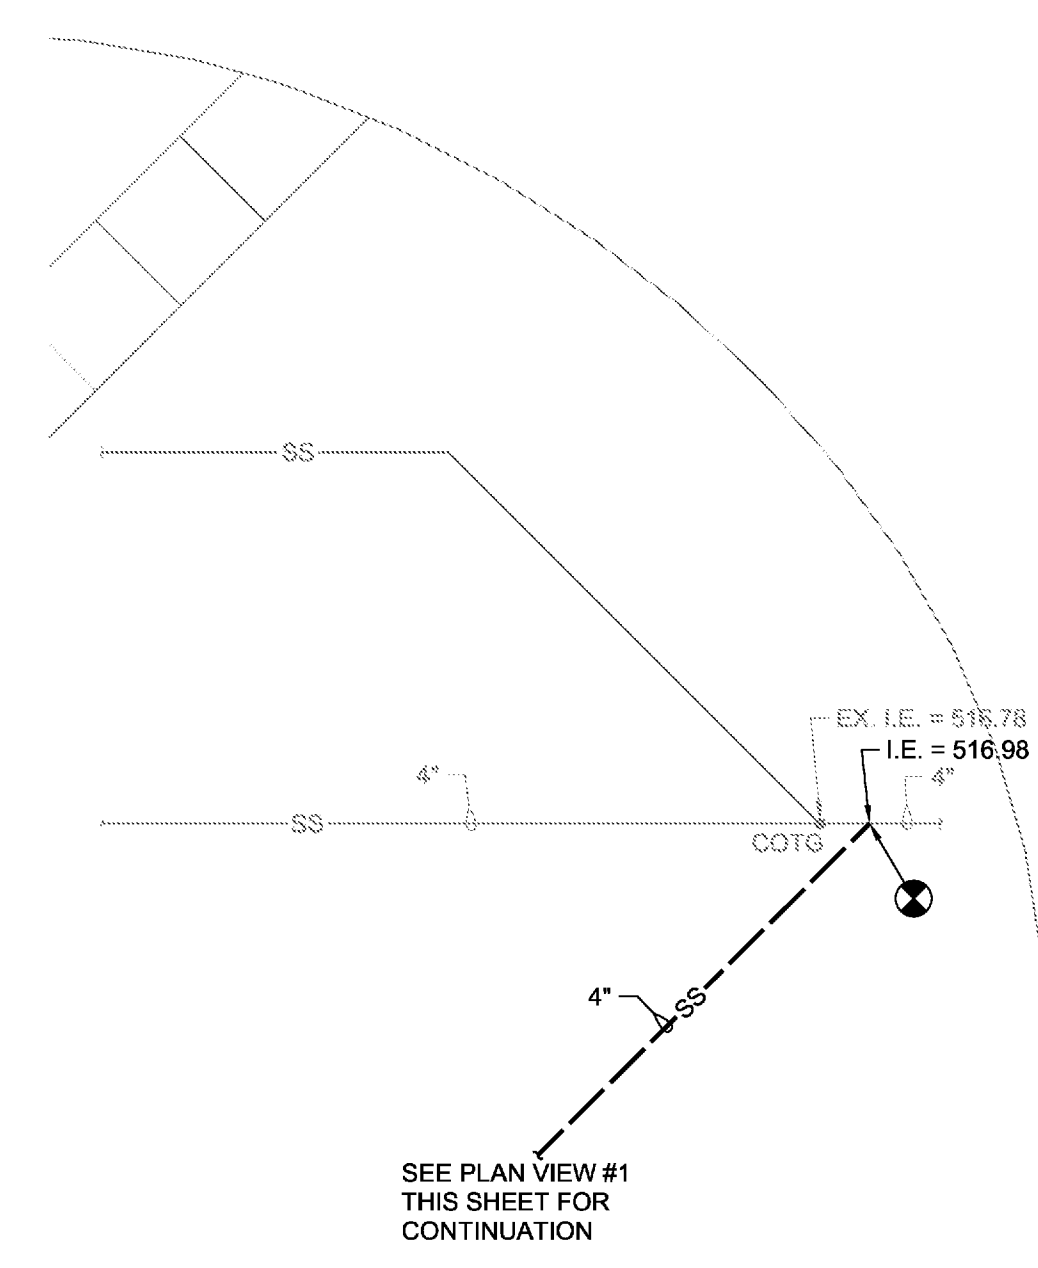

3 PARTIAL SITE PLAN - PLUMBING
1/8" = 1'-0"

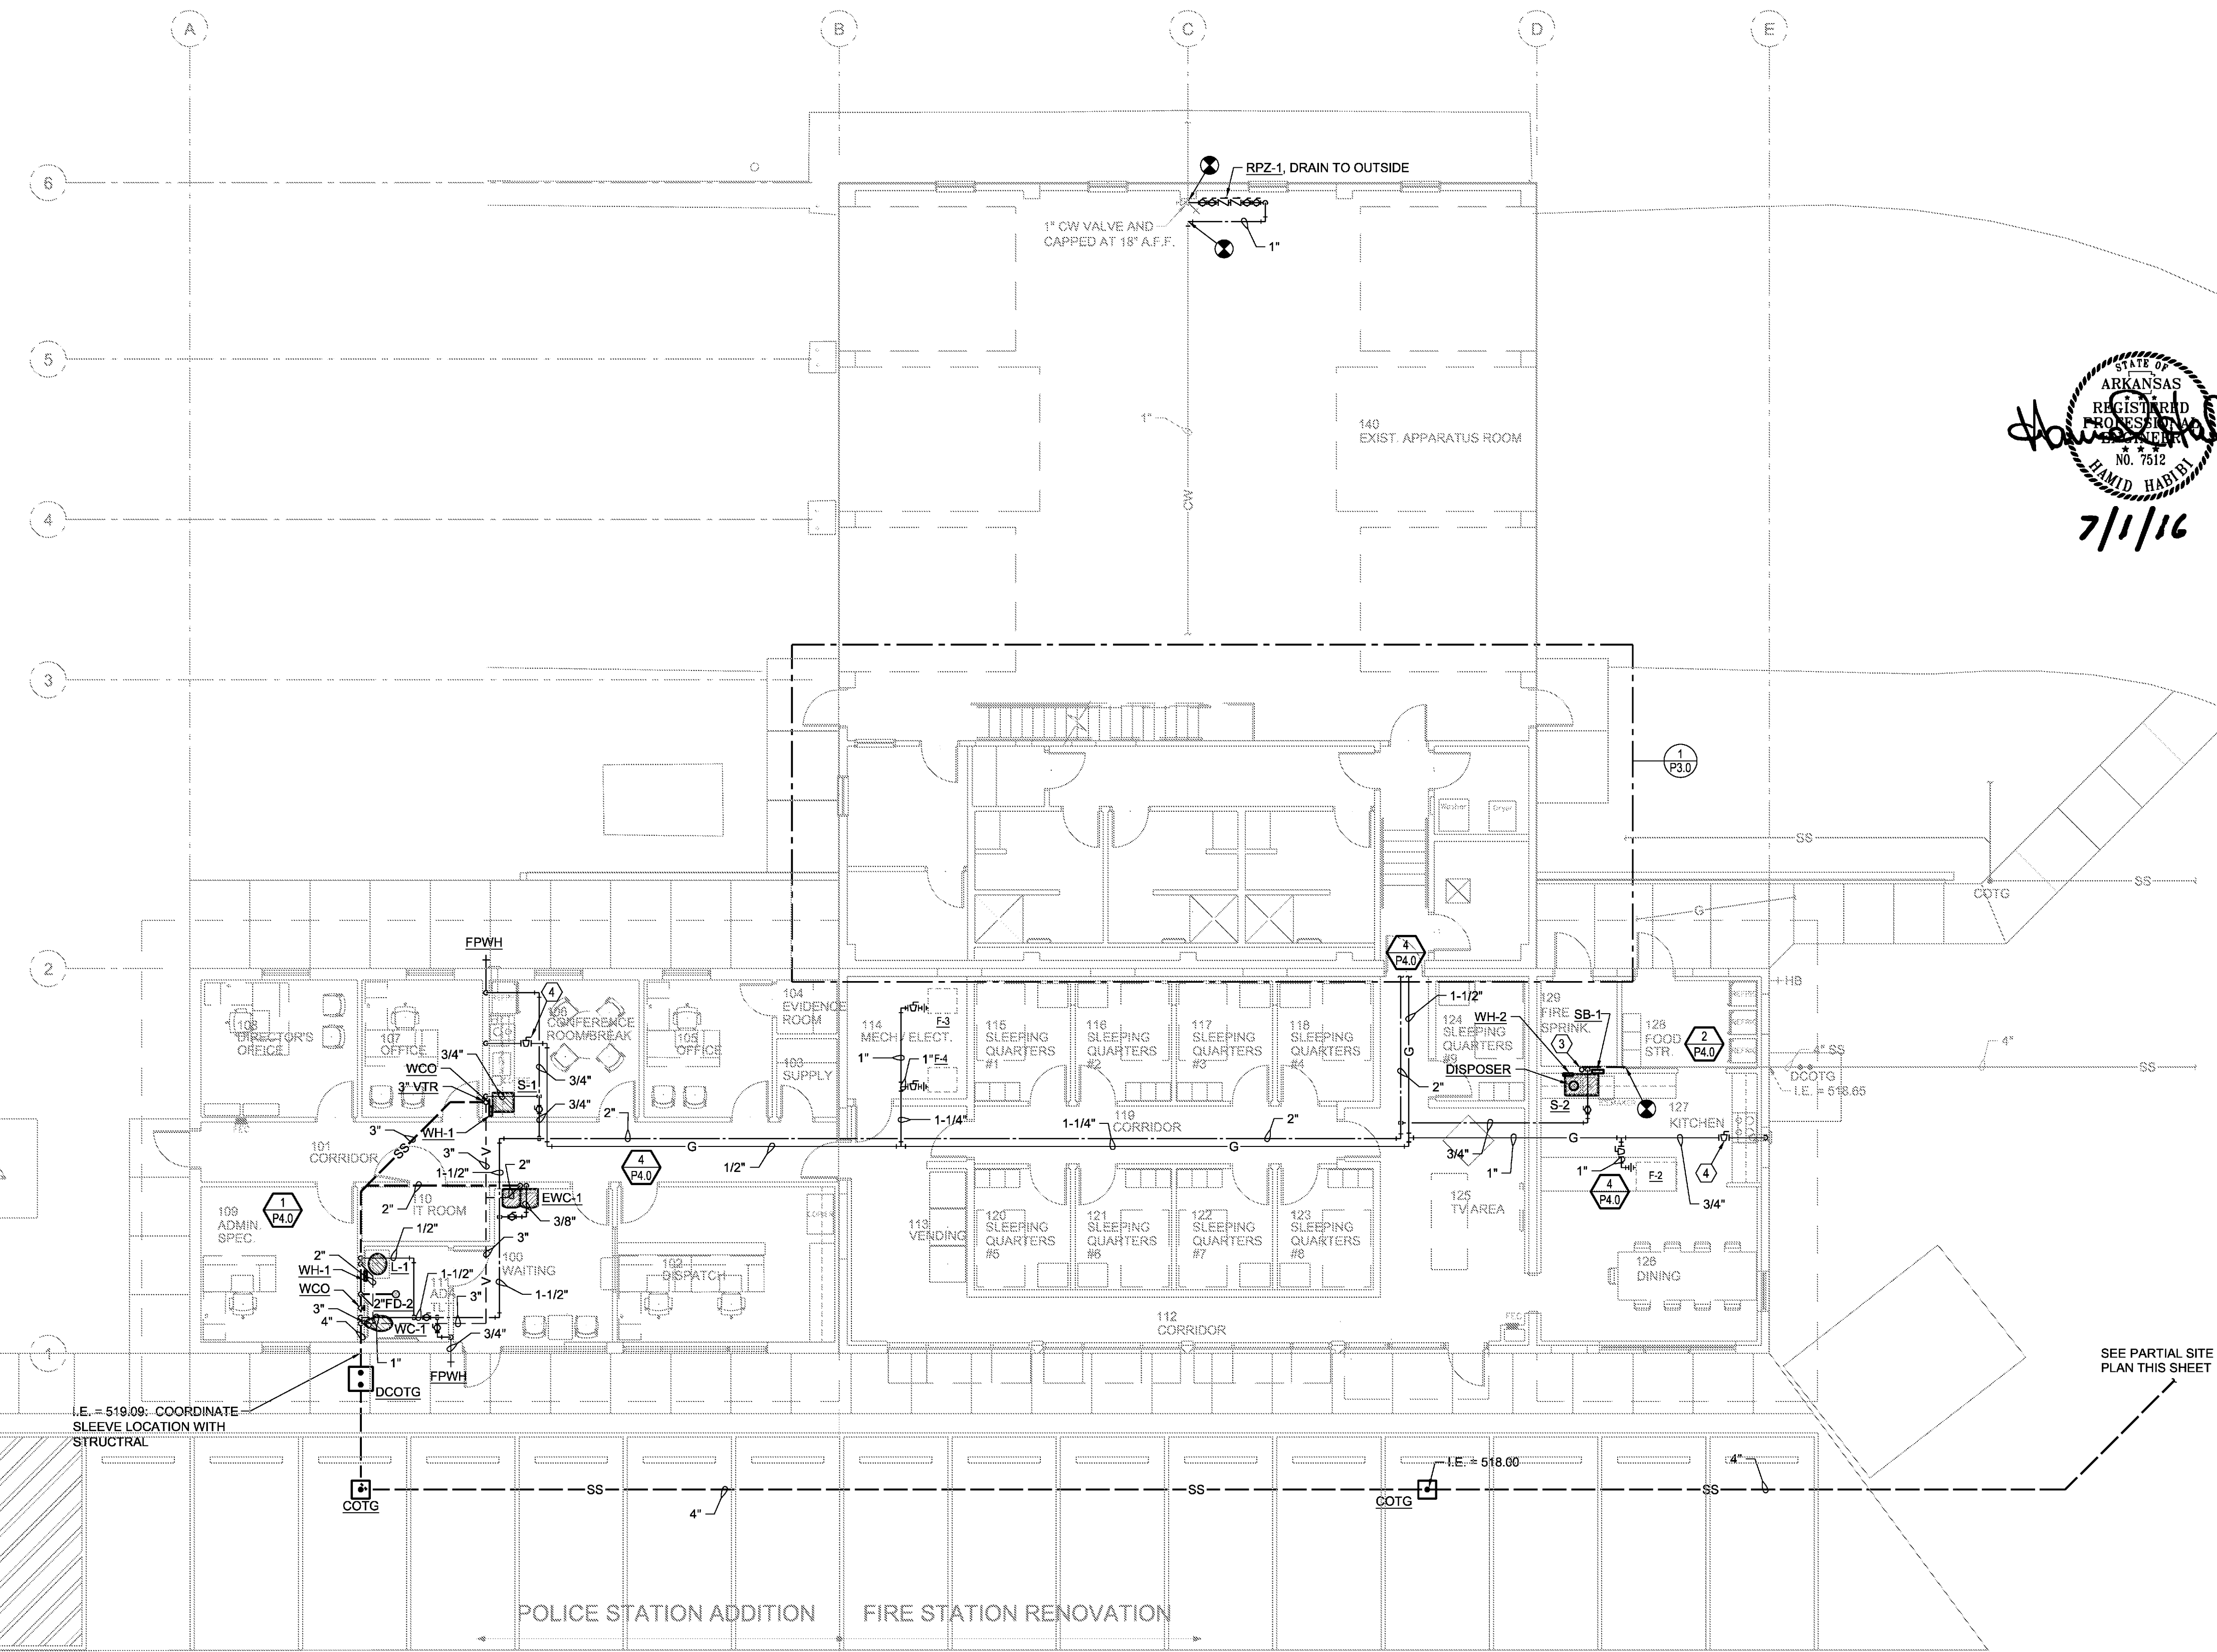

1 FLOOR PLAN - PLUMBING
1/8" = 1'-0"