


CONSULTANTS

DCI, INC.  
Civil Engineer  
ROBBINS ENGINEERING  
Structural Engineer  
TME, LLC  
MEPF Engineer

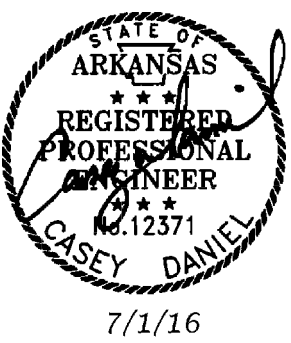

**Fire Station Renovation and  
Police Station Addition**  
Building 7200 - Camp Joseph T. Robinson  
North Little Rock, Arkansas

REVISIONS

NO.	DESCRIPTION

ISSUE DATE

07-01-16

PROJECT NO.


0901U

CONTENTS

FOUNDATION PLAN

SHEET NUMBER

**S1.1**

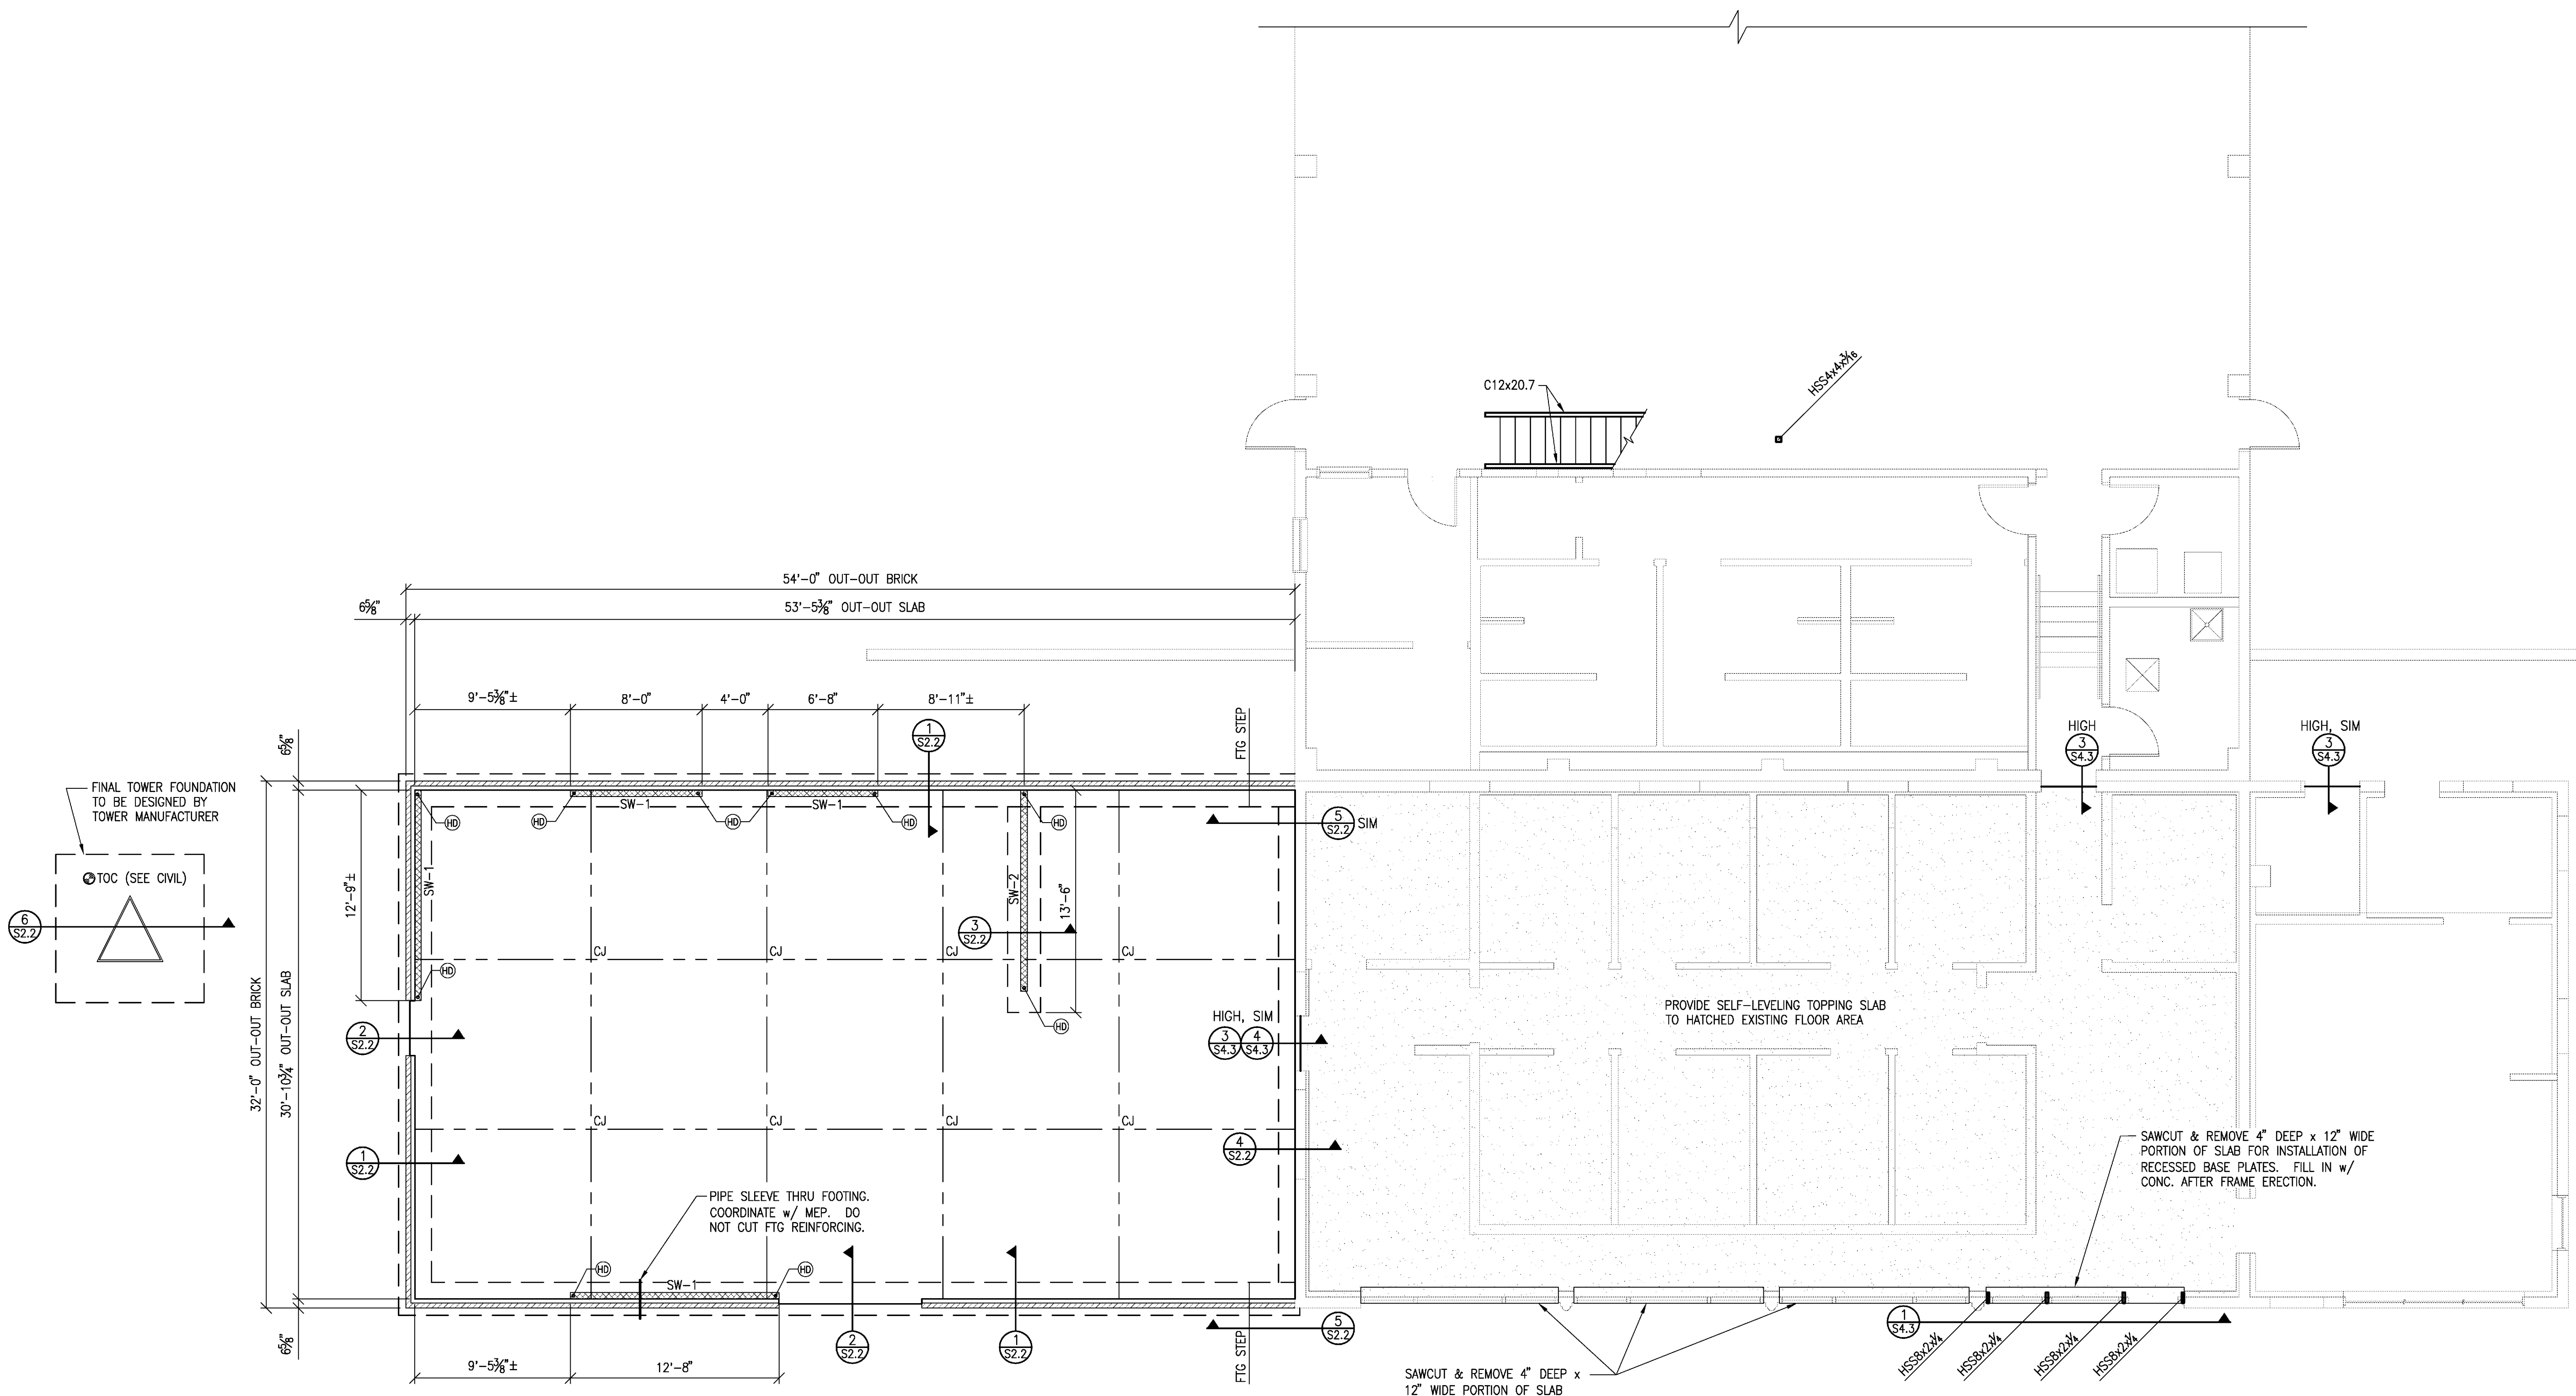

- NOTES:**
1. FIN FLR EL = 520.26'
  2. S.O.G. = 4" NORMAL WT CONCRETE ON 15-MIL VAPOR RETARDER ON 4" SELECT COMPACTED STRUCTURAL FILL. REINF W/ 6x6-W2.9xW2.9 WWF (FLAT SHEETS). PLACE REINF ON CHAIRS.
  3. CJ - INDICATES CONTROL JOINTS. SEE 1/2.1 CUT 75% OF WWF AT CONTROL JOINTS.
  4. COORDINATE SLOPING FIN FLR AREAS W/ ARCH DWGS.
  5. SW - INDICATES SHEAR WALL. SEE SCHEDULE ON S4.1
  6. (HD) - INDICATES SHEAR WALL HOLD DOWN. SEE S2.1 & S4.1
  7. VERIFY ALL DIMENSIONS W/ ARCH DRAWINGS. IF DISCREPANCIES OCCUR USE DIMENSIONS GIVEN BY THE ARCHITECT.

**FOUNDATION PLAN**  
3/16" = 1'-0"

